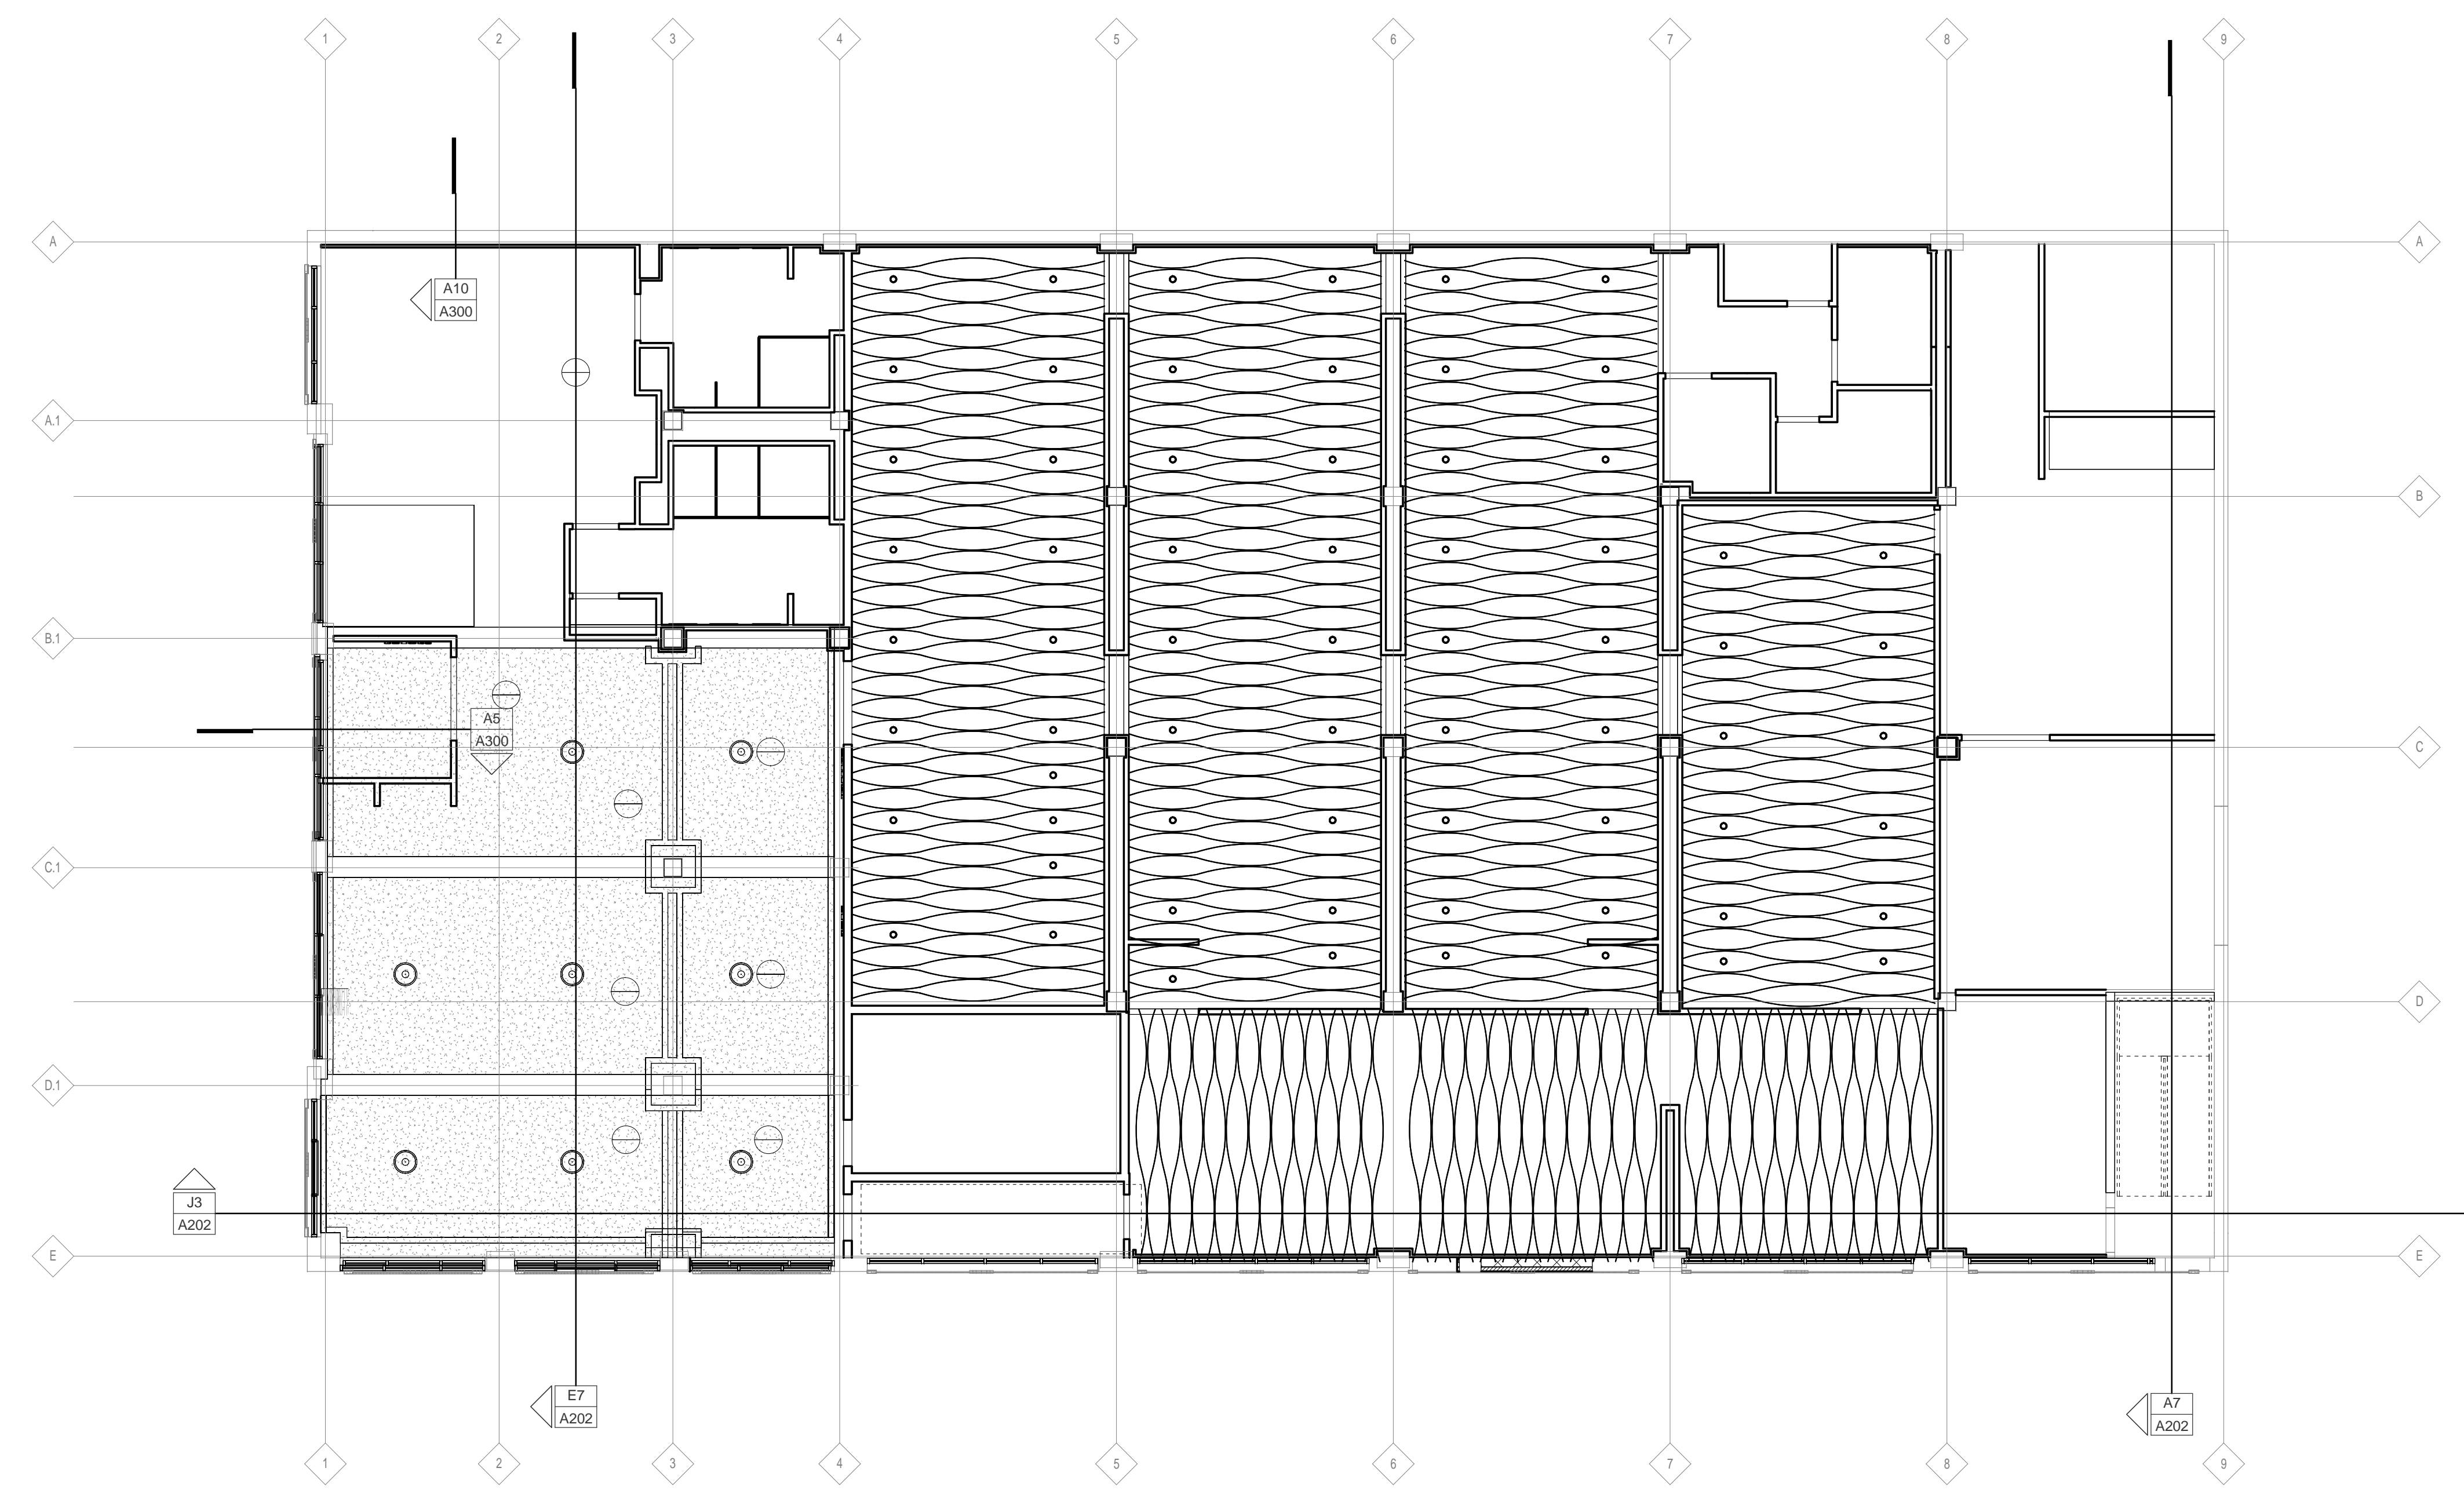


1 2 3 4 5 6 7 8 9 10 11 12

M  
L  
K  
J  
H  
G  
F  
E  
D  
C  
B  
A

 

 


KEYNOTE LEGEND

SHEET A701 SHEET SPECIFIC NOTES

NOTE 1  
DIMENSION IS FROM FACE OF PRECAST WALL PANEL TO FACE OF STUD

REFLECTED CEILING PLAN LEGEND

-  ACP-1, U.N.O.
-  NO CEILING
-  GWB

**PROJECT CONSULTANTS**

STRUCTURAL ENGINEER  
ADDRESS  
CITY  
T. 402.477.7940

CIVIL ENGINEER  
ADDRESS  
CITY  
T. 402.476.0201

MECHANICAL/ELECTRICAL ENGINEER  
ADDRESS  
CITY  
T. 402.476.1273

**Bone Creek Museum of Agrarian Art**  
Bone Creek Museum of Agrarian Art

PROJECT NO. 13001

**Ground Level Reflected Ceiling Plan**

6191 N 14th St, Lincoln, NE 68521 T. 402.435.9203

KEY PLAN


**GMP PACKAGE**  
NOT TO BE USED FOR CONSTRUCTION

7/16/2013 6:06:52 PM

**A700**

A1 GROUND LEVEL REFLECTED CEILING PLAN

SCALE: 1/8" = 1'-0"

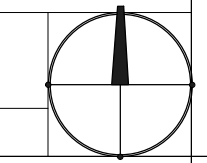

1 2 3 4 5 6 7 8 9 10 11 12